

NOTES:

1. PIPING FOR UTILITY AIR (A), PELLET OIL (POIL) AND NITROGEN (N2) SERVICES ARE NOT SHOWN ON THE PLANS. FIELD ROUTE BASED ON THE P&ID DWGS SUPPLIED BY THE DRYER SYSTEM MANUFACTURER.
2. REFER TO SPECIFICATION SECTION 15060 FOR PIPING LEGEND (SCHEDULE).
3. DRYER EQUIPMENT AND PLATFORMS PROVIDED BY ANDRITZ ARE SHOWN FOR REFERENCE ONLY. REFER TO ANDRITZ DRAWINGS FOR EXACT LOCATION AND ELEVATION OF EQUIPMENT.
4. FOR PIPING SUPPLIED BY CONTRACTOR, REFER TO DETAILS (15475-1) TO (15560)

A

B

C

D

1



2

3

4

5

6

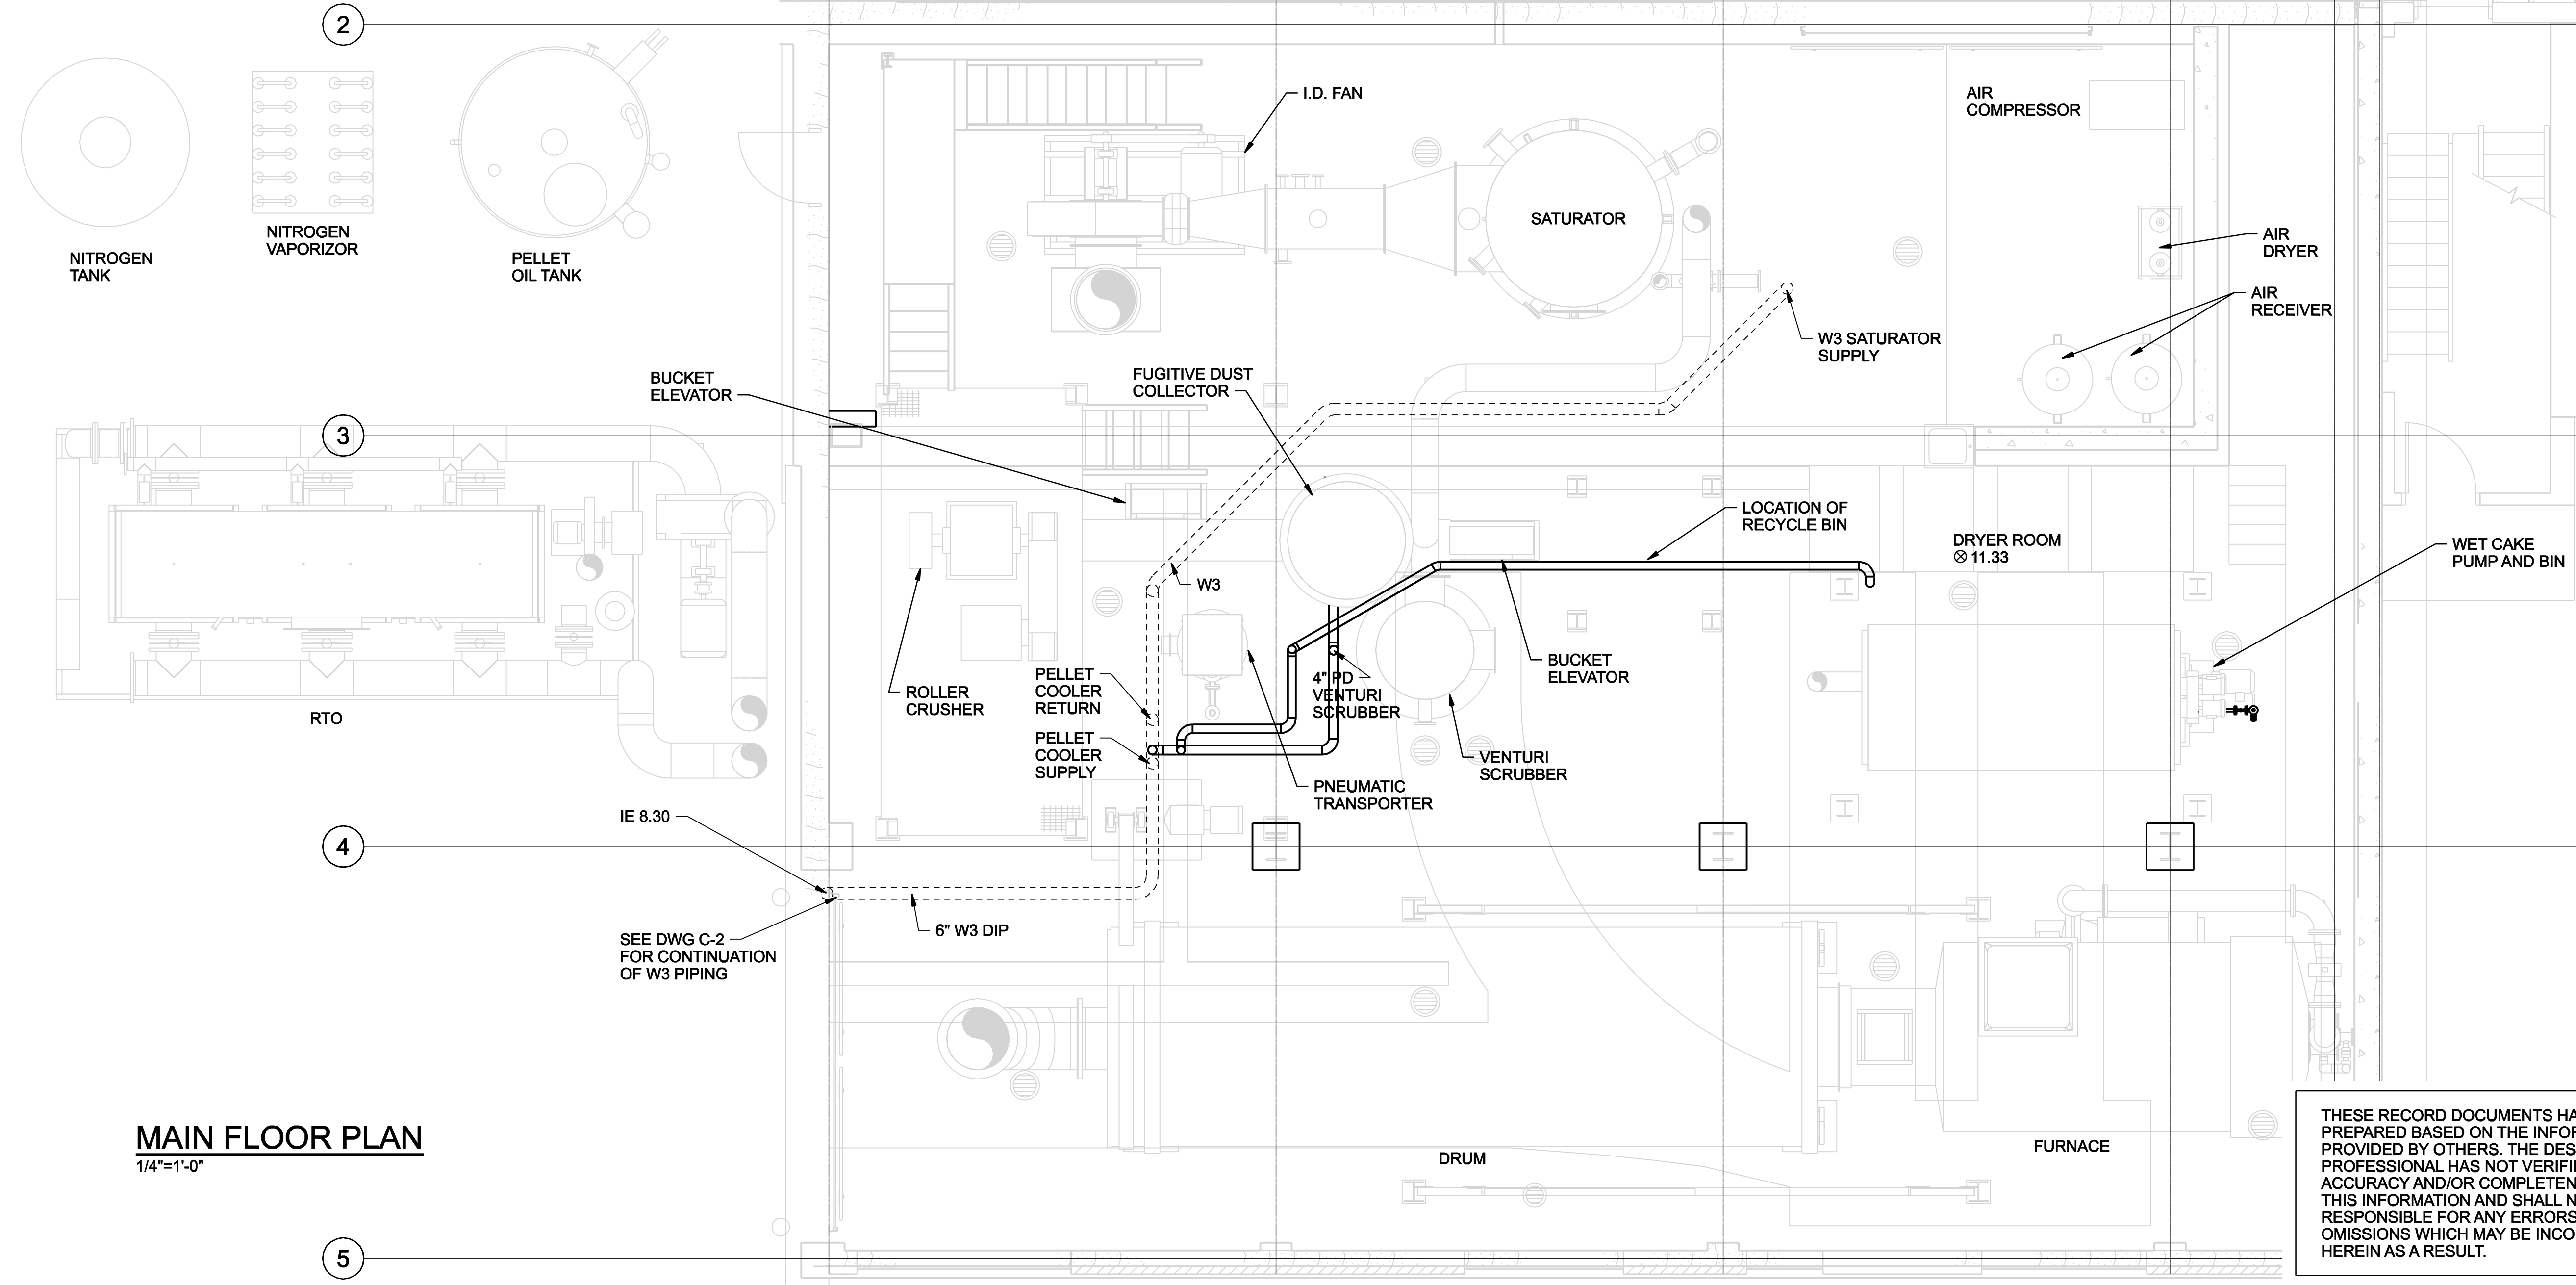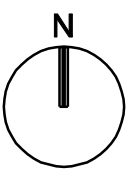

MAIN FLOOR PLAN

1/4"=1'-0"

5

THESE RECORD DOCUMENTS HAVE BEEN PREPARED BASED ON THE INFORMATION PROVIDED BY OTHERS. THE DESIGN PROFESSIONAL HAS NOT VERIFIED THE ACCURACY AND/OR COMPLETENESS OF THIS INFORMATION AND SHALL NOT BE RESPONSIBLE FOR ANY ERRORS OR OMISSIONS WHICH MAY BE INCORPORATED HEREIN AS A RESULT.

RECORD DRAWING	BG	BG	APVD
RE-ISSUED FOR CONSTRUCTION	BG	PW	BG
ISSUED FOR CONSTRUCTION	BG	PW	BG
FOR FINAL REVIEW/ BUILDING PERMIT	BG	PW	BG
REVISION	NO.	DATE	BY
1	01/20/08	S LAROCCOUE	DR
2	09/08/06	P SINGH	CHK
3	07/04/06	D LYNCH	APVD
4	06/05/06	B GACKSTATTER	BY



STAMFORD WATER POLLUTION CONTROL AUTHORITY
SOLIDS DRYING PROJECT



MECHANICAL
MAIN FLOOR PLAN

VERIFY SCALE	DATE	JUNE 2006
BAR IS ONE INCH ON ORIGINAL DRAWING.	PROJ	334058
	DWG	M-2400
	SHEET	M2